
 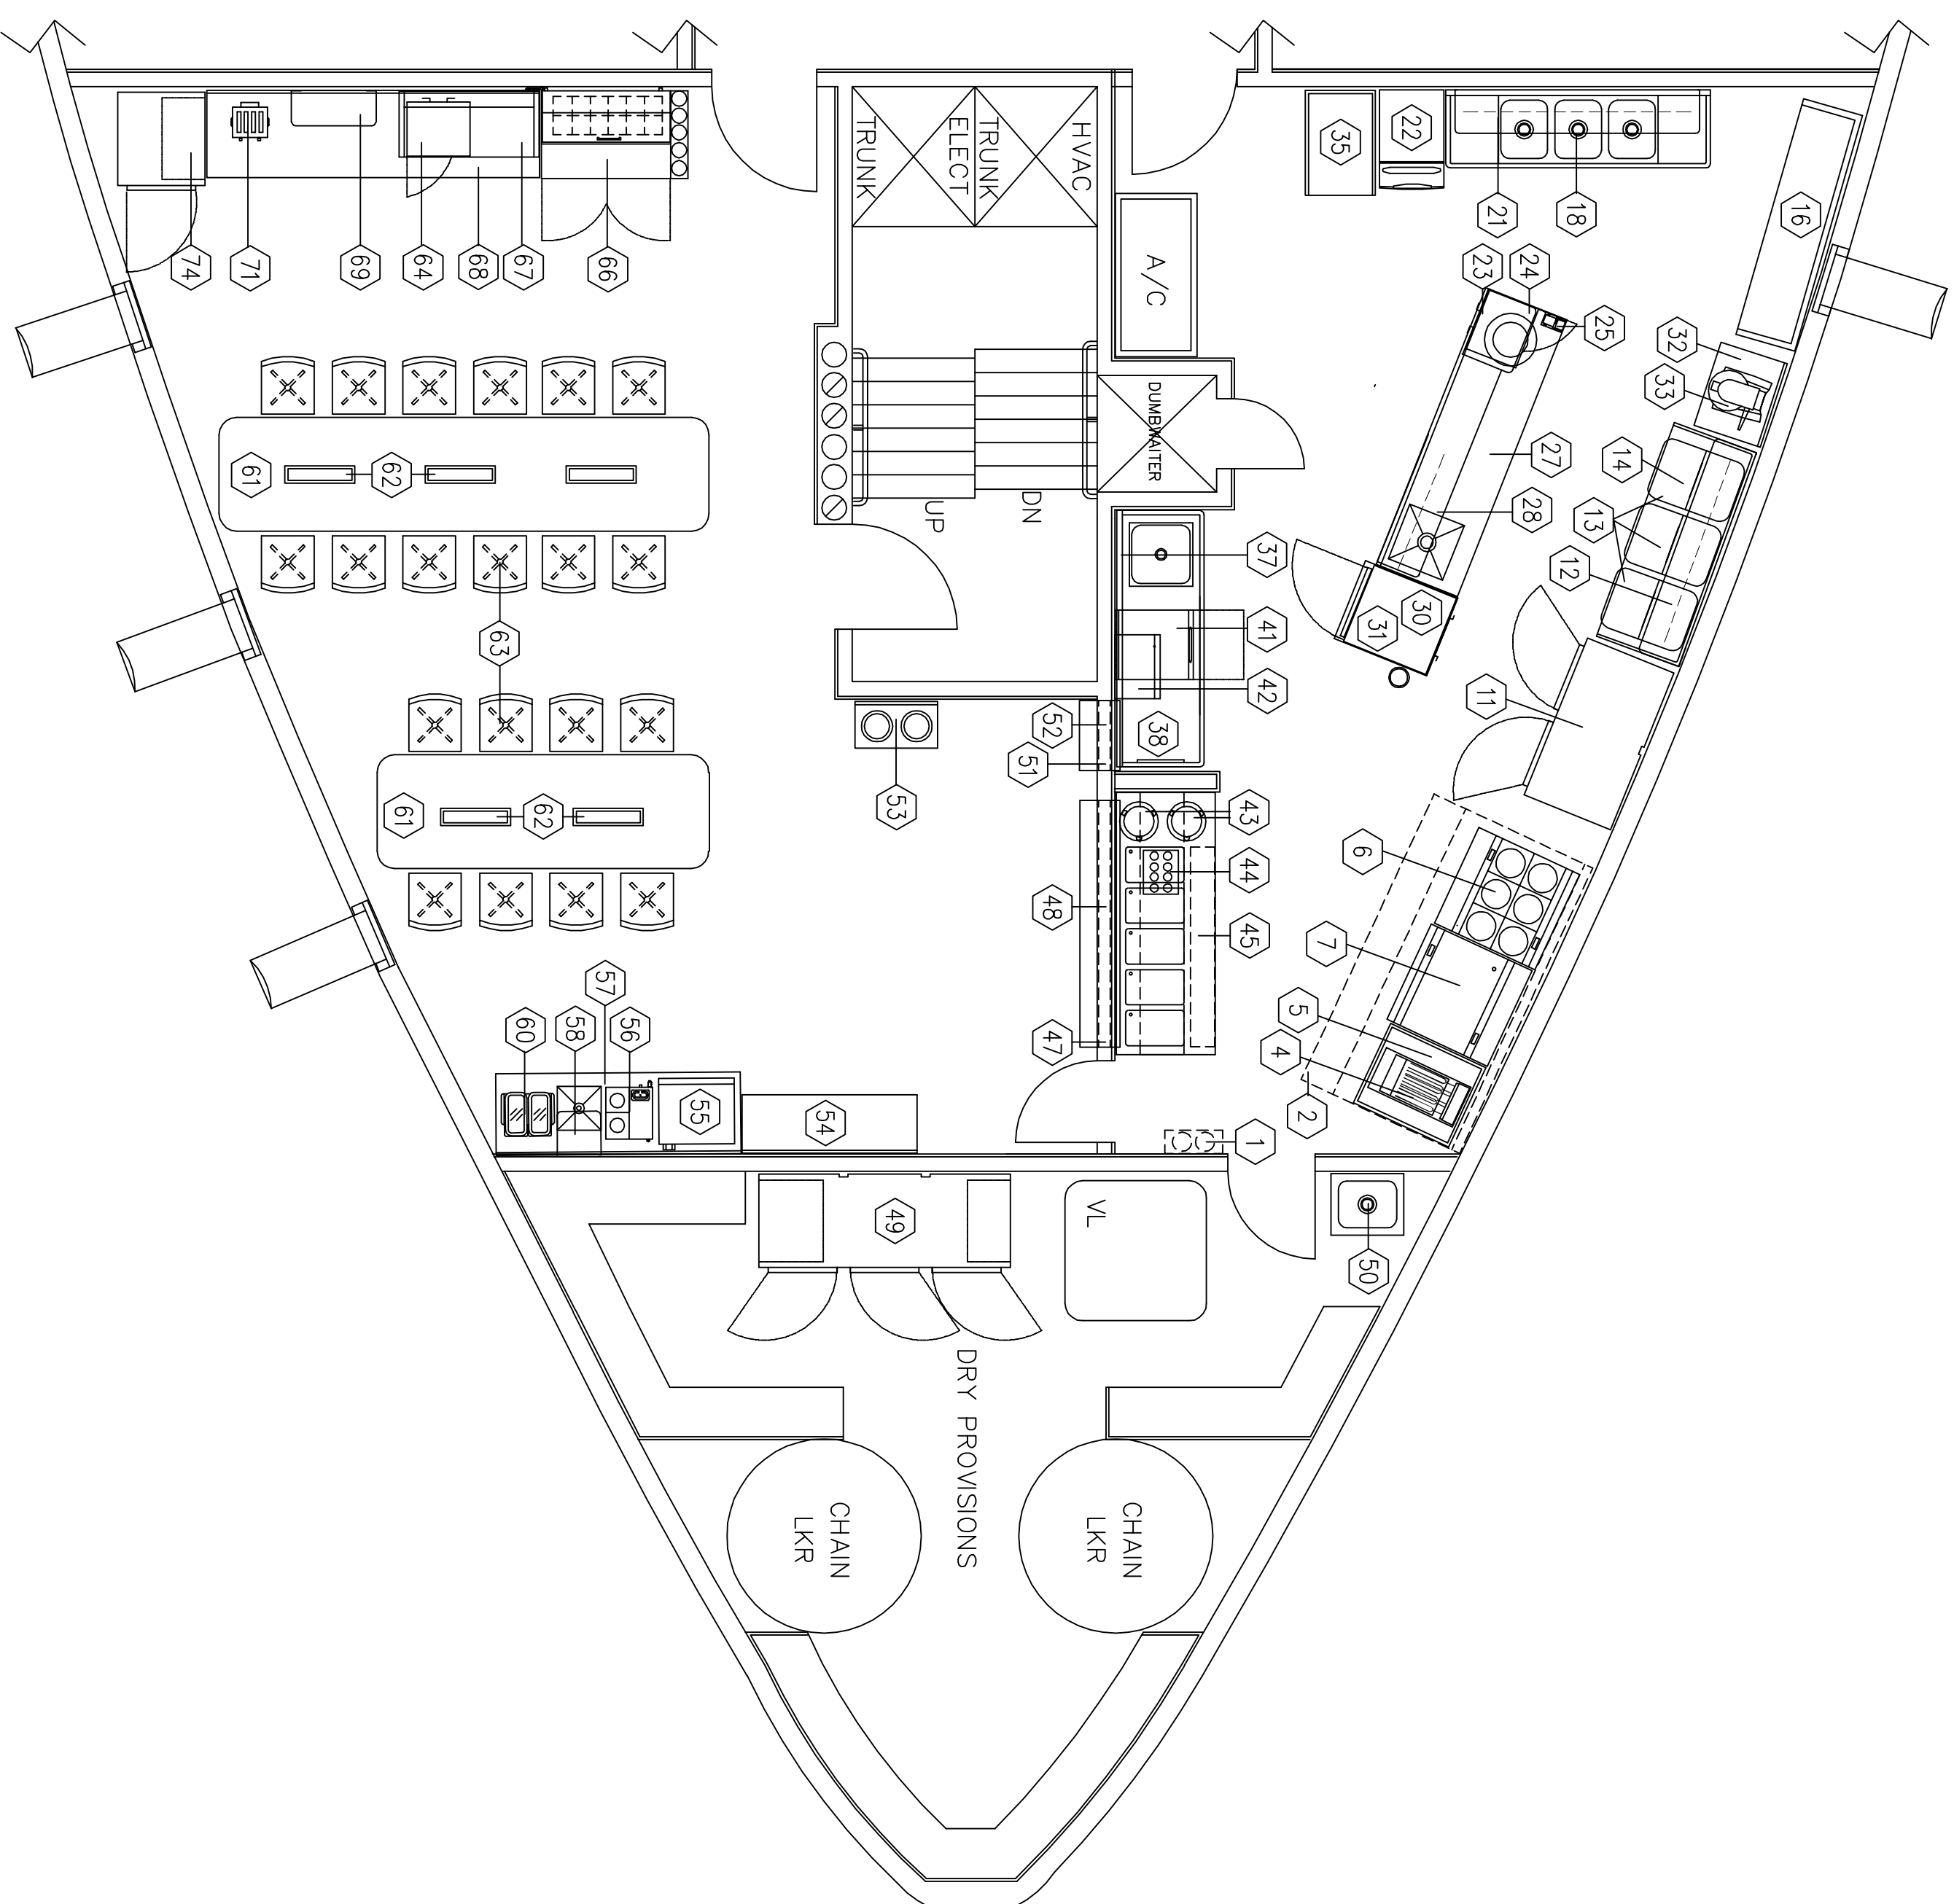


# FOOD SERVICE EQUIPMENT SCHEDULE

ITEM	QTY	DESCRIPTION	MANUFACTURER	MODEL NUMBER
1	1	LOT FIRE SUPPRESSION SYSTEM	ANSUL	R-102
2	1	LOT EXHAUST SYSTEM	CAPTIVE-AIRE	VERIFY
3		OPEN		
4	1	FRYER	LANG	C-288M
5	1	FRYER DRESSER	FLA. STAINLESS	CUSTOM
6	1	RANGE W/CONNECTION OVEN	LANG	RF21SM-H
7	1	GRIDDLE RANGE	LANG	RF21SM-G
8		OPEN		
9		OPEN		
10		OPEN		
11	1	DUAL TEMP REFRIGERATOR/FREEZER	TRAUUSEN	ROT232WUT-FHS
12	1	OVERSHELF W/UTENSIL RACK	FLA. STAINLESS	CUSTOM
13	3	INGREDIENT BINS	GAMBRO	IBS37
14	1	BAKER'S TABLE	FLA. STAINLESS	CUSTOM
15		OPEN		
16	1	POT STORAGE CABINET	FLA. STAINLESS	CUSTOM
17		OPEN		
18	1	3 COMPARTMENT SINK	FLA. STAINLESS	CUSTOM
19		OPEN		
20		OPEN		
21	1	OVERSHELF W/UTENSIL RACK	FLA. STAINLESS	CUSTOM
22	1	ICE MACHINE W/WATER FILTER	MAINIOWOC	IQ-0406A
23	1	MICROWAVE SHELF	FLA. STAINLESS	CUSTOM
24	1	MICROWAVE OVEN	SHARP	R-220V
25	1	CAN OPENER	EDLUND	S-11E
26		OPEN		
27	1	COOK'S DRESSER W/SINK	FLA. STAINLESS	CUSTOM
28	1	OVERSHELF/SPICE RACK W/UTENSIL RACK	FLA. STAINLESS	CUSTOM
29		OPEN		
30	1	TOP MOUNTED SHEET PAN RACK	FLA. STAINLESS	CUSTOM
31	1	WARNING/PROOFING CABINET	GRES-COR	H-137-WSAU-6C
32	1	EQUIPMENT DRESSER	FLA. STAINLESS	CUSTOM
33	1	20 QT. BENCH MAKER	HOBART	A200
34		OPEN		
35	1	DISH STORAGE CABINET	FLA. STAINLESS	CUSTOM
36		OPEN		
37	1	PRE-RINSE SPRAY HOSE	T&S	B-0111/B-0109-01
38	1	SOLED DISHTABLE W/PRE-RINSE SINK	FLA. STAINLESS	CUSTOM
39		OPEN		
40		OPEN		
41	1	HIGH TEMP UNDERCOUNTER DISHWASHER	HOBART	LXH-4
42	1	WALL MOUNTED RACK SHELF	FLA. STAINLESS	CUSTOM
43	2	PLATE TOWERATORS	LAKESIDE	5010
44	1	SIL VERWARE DISPENSER	STERIL-SIL	TC-85/N-200
45	1	HOT FOOD UNIT W/PLATE STORAGE & SPRING SHELF	FLA. STAINLESS	CUSTOM
46		OPEN		
47	1	SERVING WINDOW FRAME	FLA. STAINLESS	CUSTOM
48	1	SERVING WINDOW ROLL-DOWN FIRE SHUTTER	BOLTON GATE	VERIFY
49	1	3 SECTION REACH-IN REFRIGERATOR	TRAUUSEN	RHT332WUT-FHS
50	1	MOP SINK	FLA. STAINLESS	CUSTOM
51	1	DISH RETURN WINDOW FRAME	FLA. STAINLESS	CUSTOM
52	1	DISH RETURN WINDOW ROLL-DOWN FIRE SHUTTER	BOLTON GATE	VERIFY
53	1	FOOD STORAGE/TRASH RECEPTACLE	FLA. STAINLESS	CUSTOM
54	1	HU TOH STYLE DRESSER	FLA. STAINLESS	CUSTOM
55	1	ICE MAKER/DISPENSER W/WATER FILTER	SCOTSMAN	MD15N25A-18
56	1	COFFEE BREWER	BUNN	CM1F15-3
57	1	BEVERAGE SERVICE DRESSER W/SINK	FLA. STAINLESS	CUSTOM
58	1	GLASS/CUP RACK	FLA. STAINLESS	CUSTOM
59		OPEN		
60	1	BEVERAGE DISPENSER	GRATHCO	D25-3
61	2	MESS TABLES	VITRO	CUSTOM
62	5	CONDIMENT RACKS	FLA. STAINLESS	CUSTOM
63	20	MESS TABLE CHAIRS	VITRO	1500-530
64	1	MICROWAVE OVEN	SHARP	R21-JCA
65		OPEN		
66	1	REFRIGERATED SALAD BAR UNIT	FLA. STAINLESS	CUSTOM
67	1	WALL MOUNTED REF. DISPLAY CASE	DELFIELD	7048-M
68	1	MESS ROOM DRESSER	FLA. STAINLESS	CUSTOM
69	1	CERERAL BOX CABINET	FLA. STAINLESS	CUSTOM
70		OPEN		
71	1	4 SLOT TOASTER	TOASTMASTER	TP-424
72		OPEN		
73		OPEN		
74	1	DUAL TEMP REF/FREEZER	TRAUUSEN	ROT132WUT-HHS
75		OPEN		



  
 Design Group, Inc.  
 Jacksonville, Florida  
 904-543-7670  
 www.jaxdesigngroup.com

<p>Project Title</p> <h2 style="text-align: center;">TYPICAL WORKBOAT CLASS "A" GALLEY &amp; MESS DESIGN</h2>	<p>JAX Design Group, Inc.          Marine Galley          Consulting and Design          3948 South 3rd Street, #305          Jacksonville Beach, FL, 32250          904-543-7670/ Fax 543-1246          E-MAIL: jzerebny@comcast.net          www.jaxdesigngroup.com</p>	<p>THIS DRAWING &amp; SPEC'S ARE THE PROPERTY OF JAX DESIGN GROUP, INC. &amp; ARE NOT TO BE USED ON ANY WORK IN PART OR IN WHOLE EXCEPT BY WRITTEN AGREEMENT THROUGH JAX DESIGN GROUP, INC.</p> <p>THIS DRAWING IS AN INSTRUMENT OF SERVICE FOR OTHER CONTRACTORS. ALL DIMENSIONS TO BE VERIFIED ON THE JOB SITE, &amp; CONTRACTORS SHOULD CHECK WITH EQUIPMENT SUPPLIER REGARDING ROUGH-IN WORK. ALL DIMENSIONS ARE FROM FINISHED FLOORS AND WALLS. ALL STUBBING TO BE AT LEAST 3" AFF UNLESS OTHERWISE SPECIFIED. ACTUAL LOCATIONS OF FLOOR DRAINS, SIZES AND LOCATION OF VENTILATING EQUIPMENT &amp; GREASE TRAPS TO BE DETERMINED BY ARCHITECT OR ENGINEER.</p> <p>PLUMBING &amp; ELECTRICAL LOCATIONS AS SHOWN ON THE PLAN ARE OF OUTLETS AS THEY EXIST ON FIXTURES TO TAKE CARE OF CONNECTING UP TO FIXTURES.</p>										
<p>Revisions</p> <table border="1" style="width: 100%; border-collapse: collapse;"> <tr><td> </td><td> </td></tr> <tr><td> </td><td> </td></tr> <tr><td> </td><td> </td></tr> <tr><td> </td><td> </td></tr> <tr><td> </td><td> </td></tr> </table>											<p>Date: 03-20-2013          Drawn By:  <b>JOHN ZEREBNY</b>  <b>FCSI #705968</b>          Scale: 1/4" = 1'0"</p>	<p style="text-align: center;"><b>FLOOR PLAN</b></p> <p style="text-align: center;">Sheet Number  <span style="font-size: 2em; font-weight: bold;">FS-1</span></p>